


	YOU ARE HERE
	ESCAPE ROUTE
	ESCAPE STAIR
	ESCAPE CORRIDOR
	FIRE ALARM PANEL
	REPEATER FIRE ALARM PANEL
	RED BREAK GLASS UNIT
	MAINTAINED DIRECTIONAL EXIT SIGNAGE
	ASSEMBLY POINT
	FIRE HYDRANT
	EXTINGUISHER - WATER
	EXTINGUISHER - DRY POWDER
	EXTINGUISHER - CO ₂
	EXTINGUISHER - FOAM
	EXTINGUISHER - WET CHEMICAL
	FIRE BLANKET
	EVACUATION SSI SHEET

H

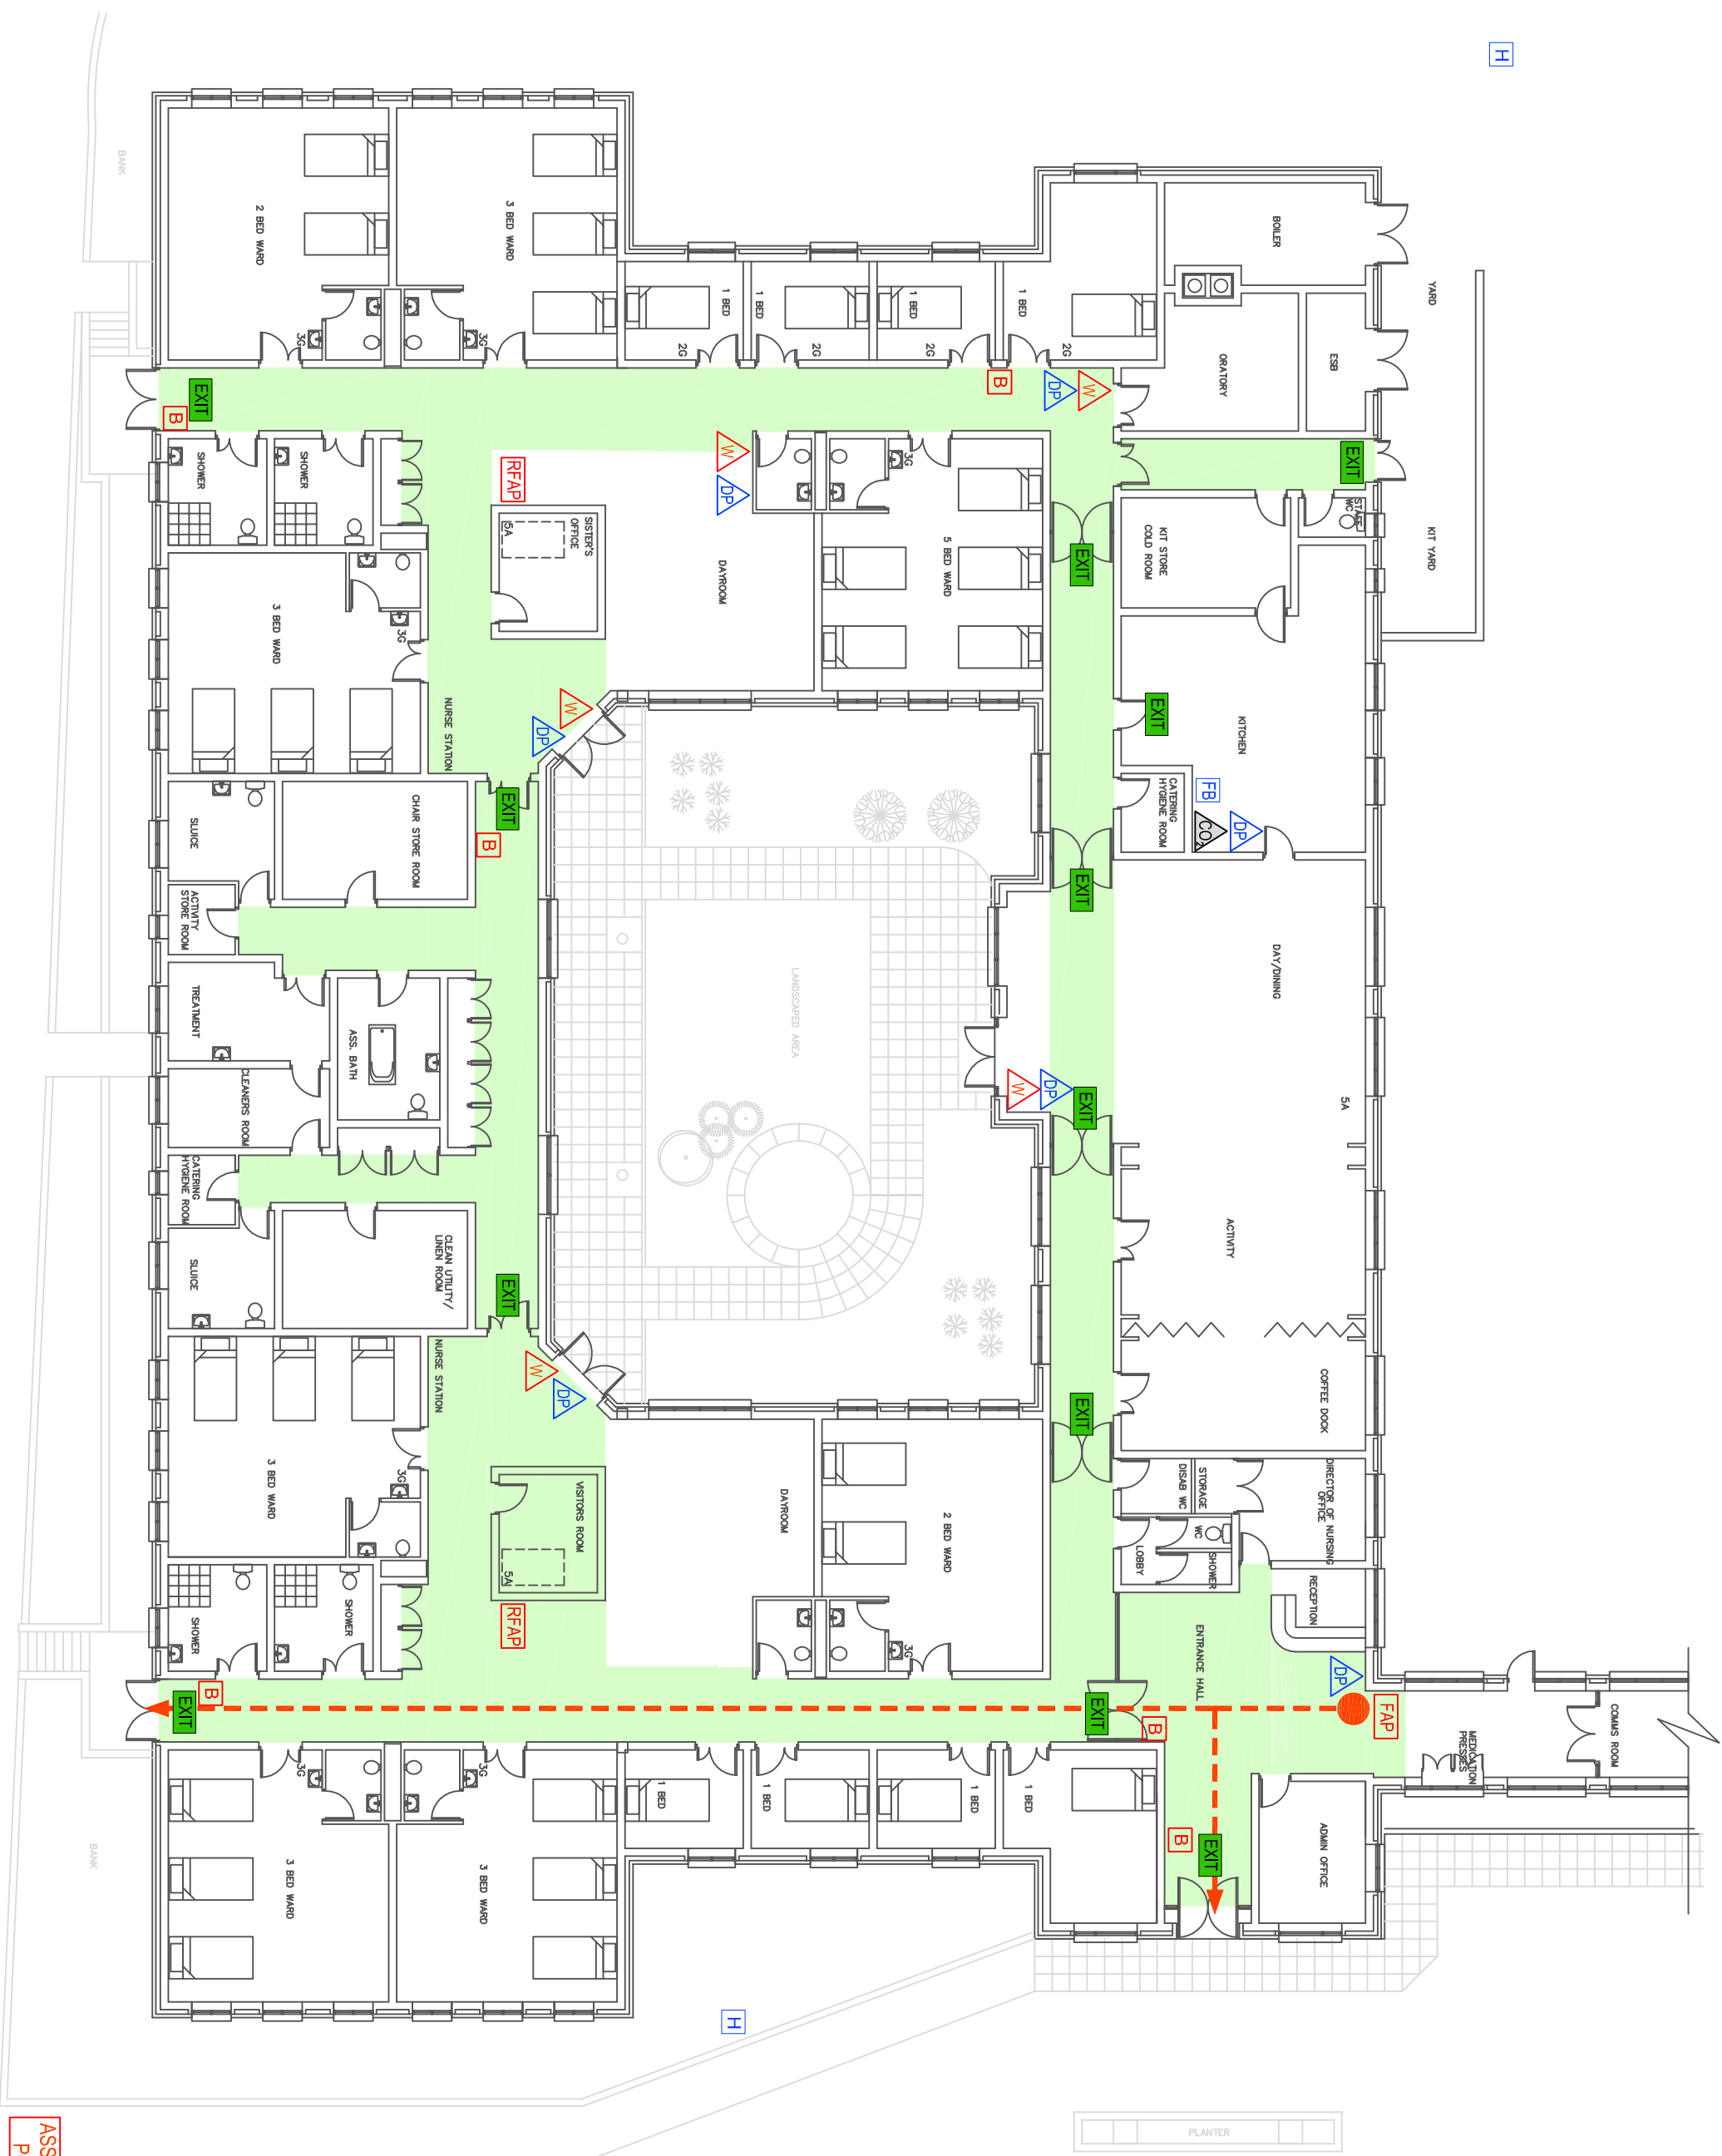

ASSEMBLY POINT

ASSEMBLY POINT

Fíréannacht na Seirbhíse Slánte
Health Service Executive

Tel: +353 (0) 46 925 1350

Project
ST. MARY'S ELDERLY UNIT
DROGHEDA, CO. LOUTH

Title
FIRE EVACUATION STRATEGY
GROUND FLOOR PLAN

Scale
N/A

Drawing No.
001

Revision
A